


**FOSKETT STREET**

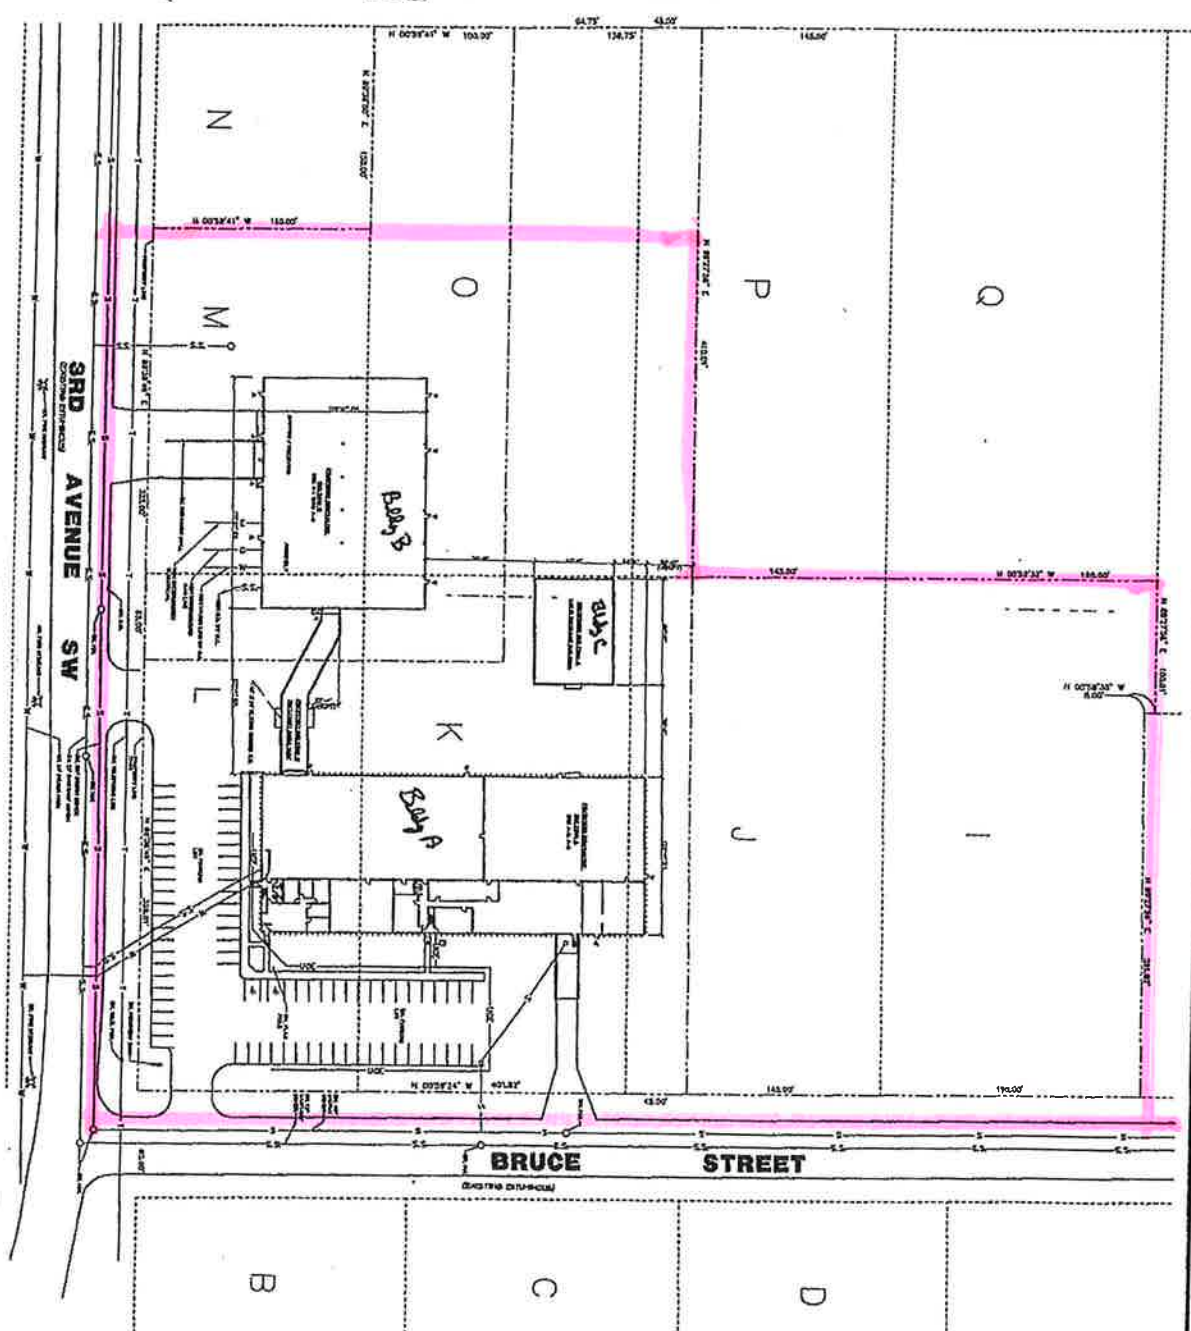

**BRUCE STREET**

**3RD AVENUE SW**

**PHOENIX INDUSTRIES**  
CROOKSTON, MINNESOTA  
PROPOSED SITE PLAN

DATE: 8-3-2009  
PLAN SCALE: 1" = 1'  
DRAWN BY: JAL  
CHECKED BY: RJA  
JOB NO. 8800242

DATE	REVISION	DESCRIPTION	BY

I HEREBY CERTIFY THAT THE PLANS, SPECIFICATIONS, AND REPORTS WAS PREPARED BY ME OR UNDER MY CLOSE SUPERVISION AND THAT I AM A DULY LICENSED PROFESSIONAL ENGINEER UNDER THE LAWS OF THE STATE OF MINNESOTA.

**WILDSRITH SMITH NOLTING**  
ENGINEERS AND ARCHITECTS  
LAND SURVEYORS  
ENVIRONMENTAL SERVICES